

### SHEET NOTES

- TUBE STEEL COLUMN, PROVIDE 24 GA. BRUSHED STAINLESS STEEL COLUMN COVER W/ LAP SEAMS 60° A.F.F. PAINT P-8 FROM 80 A.F.F. TO 12" ABOVE CEILING TYP. SEAL TOP OF COVER W/ CLEAR SILICONE. SEE STRUCTURAL DRAWINGS FOR MORE INFORMATION.
- LINE OF CONCRETE CURB. SEE CIVIL DRAWINGS FOR MORE INFORMATION.
- PLUMBING FIXTURE LOCATION. SEE PLUMBING DRAWINGS FOR MORE INFORMATION.
- CURT GUARD RAILING. SEE SPECIFICATIONS.
- ROOF DRAIN / OVERFLOW PIPING LOCATION. SEE PLUMBING DRAWINGS FOR MORE INFORMATION.
- LINE OF MEZZANINE ABOVE. SEE SHEET A-604 FOR MORE INFORMATION.
- LINE OF MEZZANINE STAIRS. SEE SHEET A-703 FOR MORE INFORMATION.
- LINE OF SOFFIT ABOVE. SEE REFLECTED CEILING PLAN FOR MORE INFORMATION.
- EXTERIOR GLAZING. SEE SHEET A-201.
- FIXTURES & FIXTURE PLACEMENT TO BE PROVIDED BY OTHERS.
- INTERIOR GLAZING SYSTEM. SEE ELEVATIONS.
- NOT USED.
- INTERIOR WALL TO 5'-0" A.F.F. ENCLOSE TOP OF WALL WITH GYP. BO. FINISH.
- TUBE STEEL COLUMN TO BE WRAPPED PER DETAIL A9/A-801.
- SECURE PRECASTS BY RITE AID. SEE SPECIFICATIONS FOR MORE INFORMATION.
- 4'-0" HIGH MANSOET OF 3/4" FIRE TREATED O.S.B.
- WALLS ALL TO RECEIVE MARBLE PANELS PP-1 TO 8'-0" A.F.F.
- ALGON FINISH FACES W/ SOFFIT ABOVE.
- FOR FURTHER DETAIL SEE ENLARGED PLAN.
- BASED DRIVE-THRU ISLAND. SEE SHEET A-201.
- PNEUMATIC UNIT

### GENERAL NOTES

- PLAN DIMENSIONS ON THIS SHEET AND LARGE SCALE DRAWINGS ARE TO FACE OF GYP. BO. U.O.N.
- FINAL FIXTURE LOCATIONS SHALL BE PER RITE AID APPROVED FIXTURE PLAN.

### LEGEND (SEE D5/G001 FOR SYMBOLS LEGEND)

- EXTERIOR MASONRY WALL
- LOW PARTITION SEE PARTITION TYPES THIS SHEET
- FULL HEIGHT PARTITION SEE PARTITION TYPES THIS SHEET
- EXTERIOR METAL STUD WALL
- PARTITION KEY (SEE K1/ A-101)

### LIMITING HEIGHTS


#### INTERIOR STUD FRAMING

STUD	STUD	ALLOW. PARTITION DEF.	PARTITION (1) LAYER	PARTITION (2) LAYER	FURRING (1) LAYER
25 GAUSE (0179 MIN.)					
1585725	1 5/8"	14"	L/240 8'5"	10'9"	8'3"
2125725	2 1/2"	16"	L/240 12'6"	13'9"	11'0"
3085725	3 5/8"	16"	L/240 16'0"	19'3"	16'6"
4005725	4"	16"	L/240 17'3"	17'3"	15'9"
6005725	6"	24"	L/240 15'0"	15'0"	15'0"
22 GAUSE (0270 MIN.)					
2125722	2 1/2"	16"	L/240 13'0"	14'0"	12'0"
3085722	3 5/8"	16"	L/240 17'3"	18'0"	16'0"
4005722	4"	16"	L/240 18'6"	19'3"	17'3"
6005722	6"	16"	L/240 20'0"	20'0"	20'0"
20 GAUSE (0312 MIN.)					
2125720	2 1/2"	16"	L/240 13'0"	14'0"	12'0"
3085720	3 5/8"	16"	L/240 17'3"	18'0"	16'0"
4005720	4"	16"	L/240 18'6"	19'3"	17'3"
6005720	6"	24"	L/240 22'0"	22'0"	22'0"
SI STYLE (0314 MIN.)					
3085720	3 5/8"	16"	L/240 19'0"	19'0"	18'0"
4005720	4"	16"	L/240 20'0"	21'0"	19'0"
6005720	6"	24"	L/240 22'0"	22'0"	22'0"

### PARTITION LATERAL BRACING SCHEDULE

PARTITION LENGTH	MINIMUM	MAXIMUM	NUMBER OF BRACES REQUIRED
0'-0"	12'-0"	0	
12'-0"	18'-0"	1	
18'-0"	24'-0"	2	
24'-0"	30'-0"	3	

ADD ONE BRACE PER EACH ADDITIONAL 6'-0" OF PARTITION LENGTH.  
PARTITION LENGTH BETWEEN LATERAL SUPPORT PROVIDED BY LATERAL SUPPORT OR INTERSECTING PERPENDICULAR PARTITIONS.  
PROVIDE LATERAL BRACING AT UNSUPPORTED PARTITION ENDS.  
PROVIDE LATERAL BRACING FOR ALL PARTITIONS WHICH DO NOT EXTEND TO STRUCTURE.

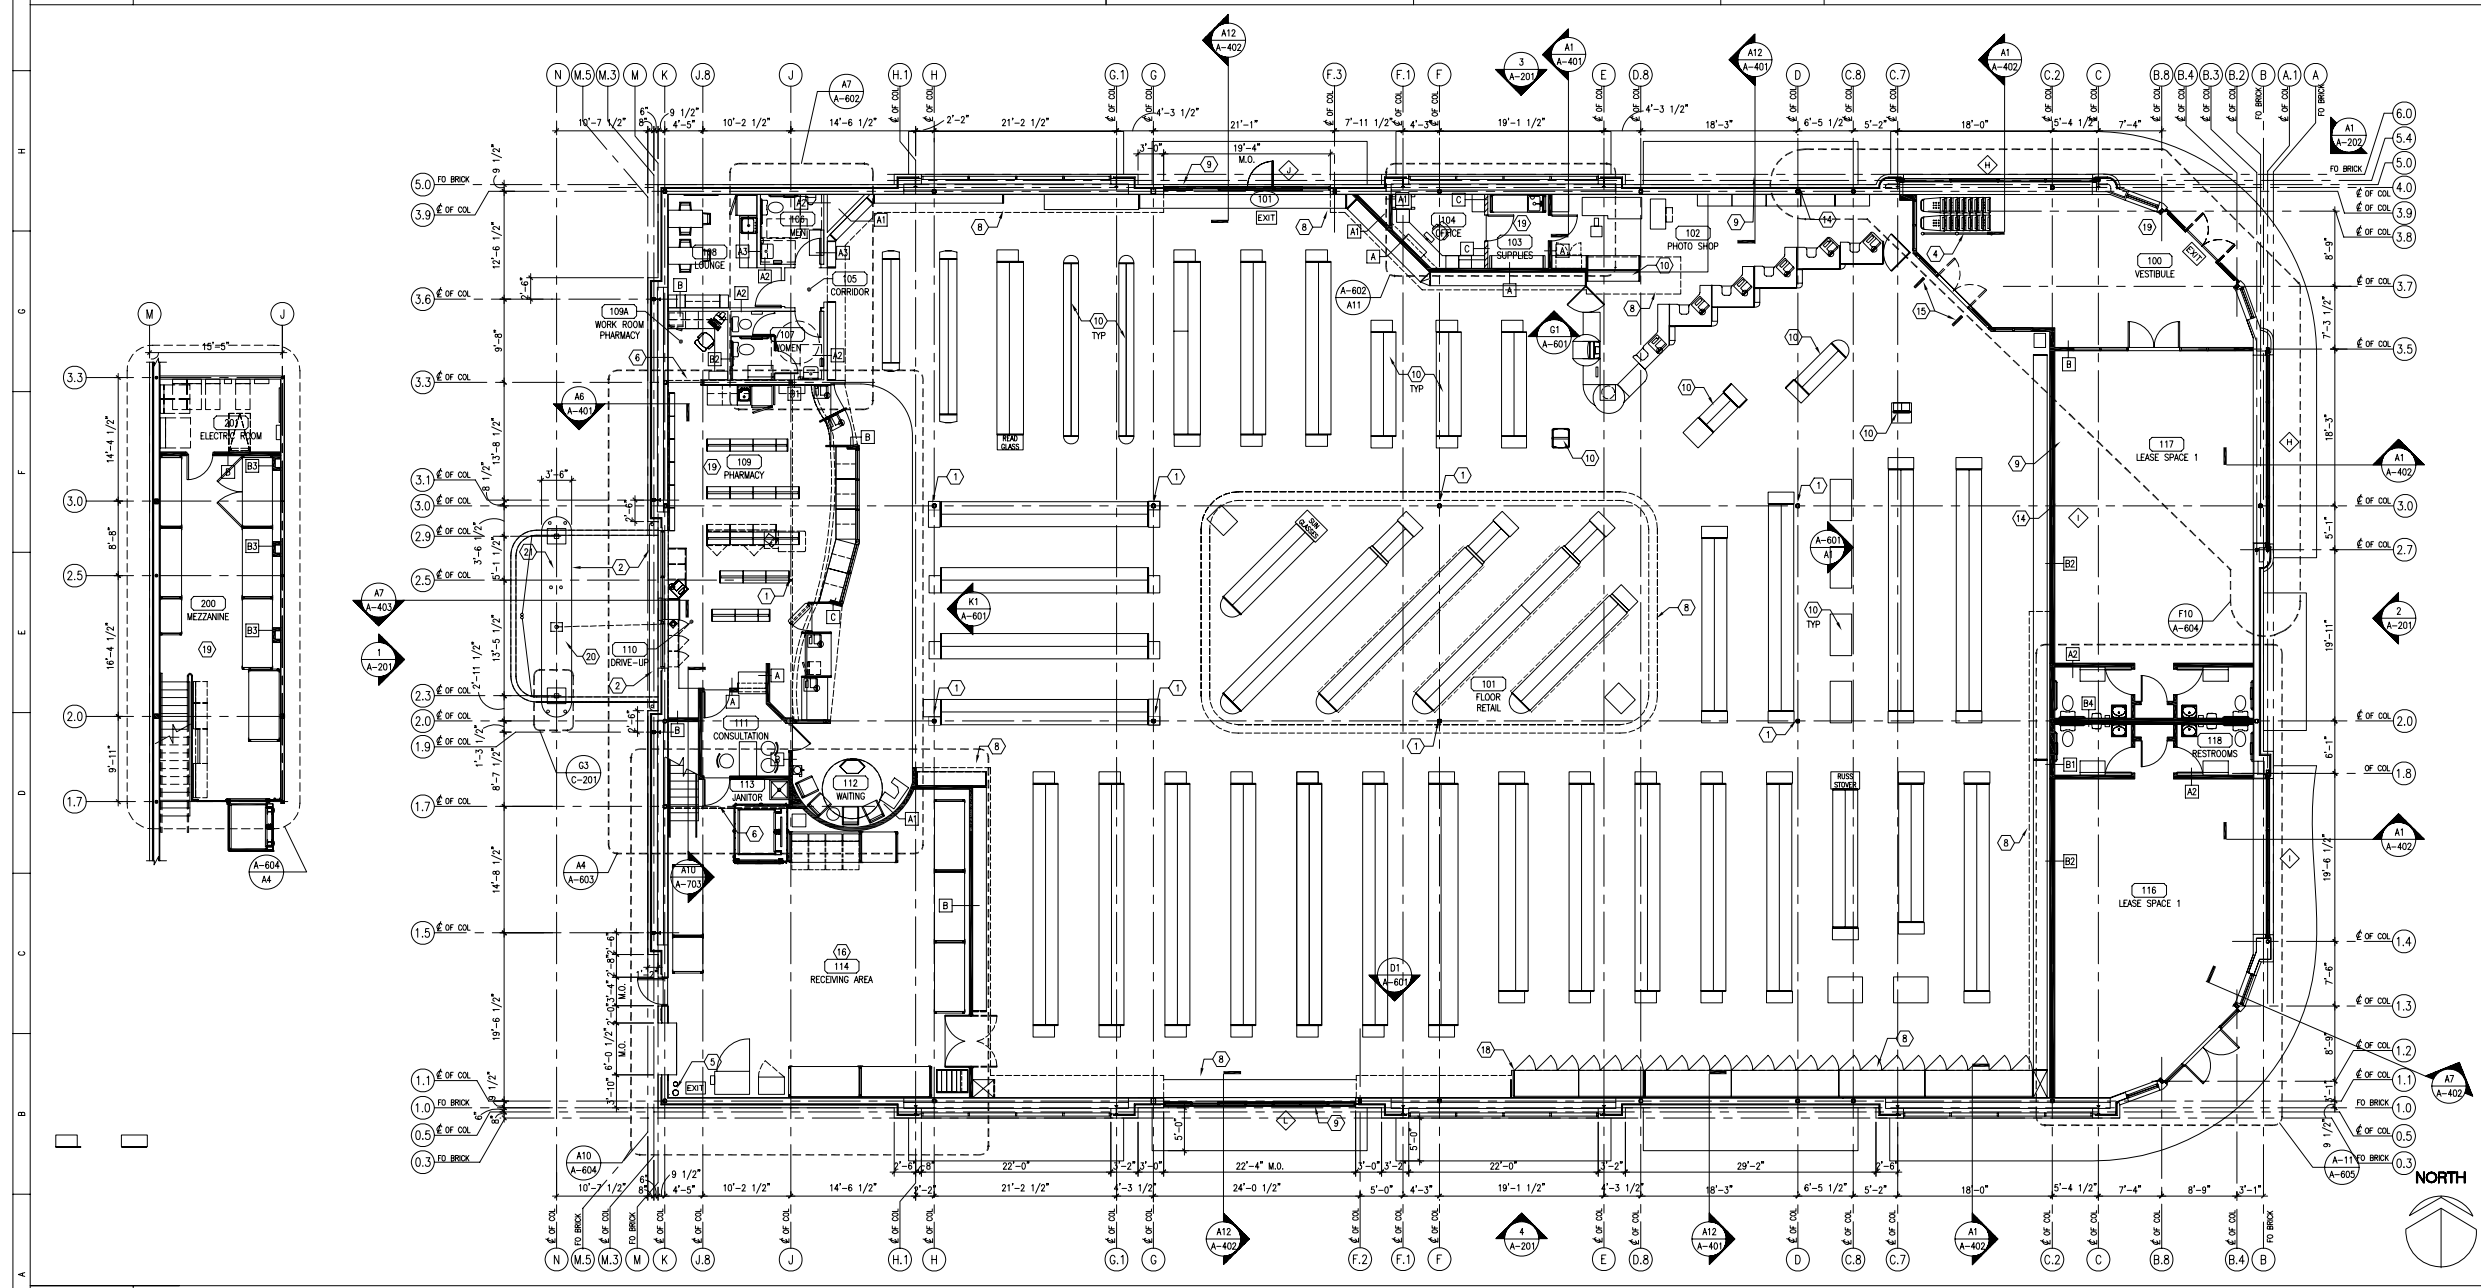

**A1 FLOOR PLAN**  
1/8" = 1'-0"

ARCHITECTURE ENGINEERING ENVIRONMENTAL SERVICES  
1550 140th AVENUE N.E., SUITE 100, BELLEVUE, WA 98005-4516  
TEL: (425) 746-4677

**RHL**  
DESIGN GROUP INC.

**RITE AID CORPORATION**  
STORE DEVELOPMENT DEPARTMENT  
P.O. BOX 3165  
HARRISBURG, PA 17105  
(717) 761-2633

**WORLD PLAN  
PROTOTYPE**  
107 x 163 W/ LEASE SPACE

OLYMPIA RETAIL  
RITE AID  
OLYMPIA, WA

**STORE NO. 5278-04**  
3202 HARRISON AVENUE NW  
OLYMPIA, WA

No.	Date	Description
1	07.28.05	PERMIT SET

No. Date Description  
Current Photo Date: 05.26.05  
Project no: 07D004-2  
Cadd Drawing File: 5240-A101  
Drawn By: SSM/KAW  
Checked By: RTD

Sheet Title  
**FIRST FLOOR PLAN**

Sheet Number  
**A-101.6**